



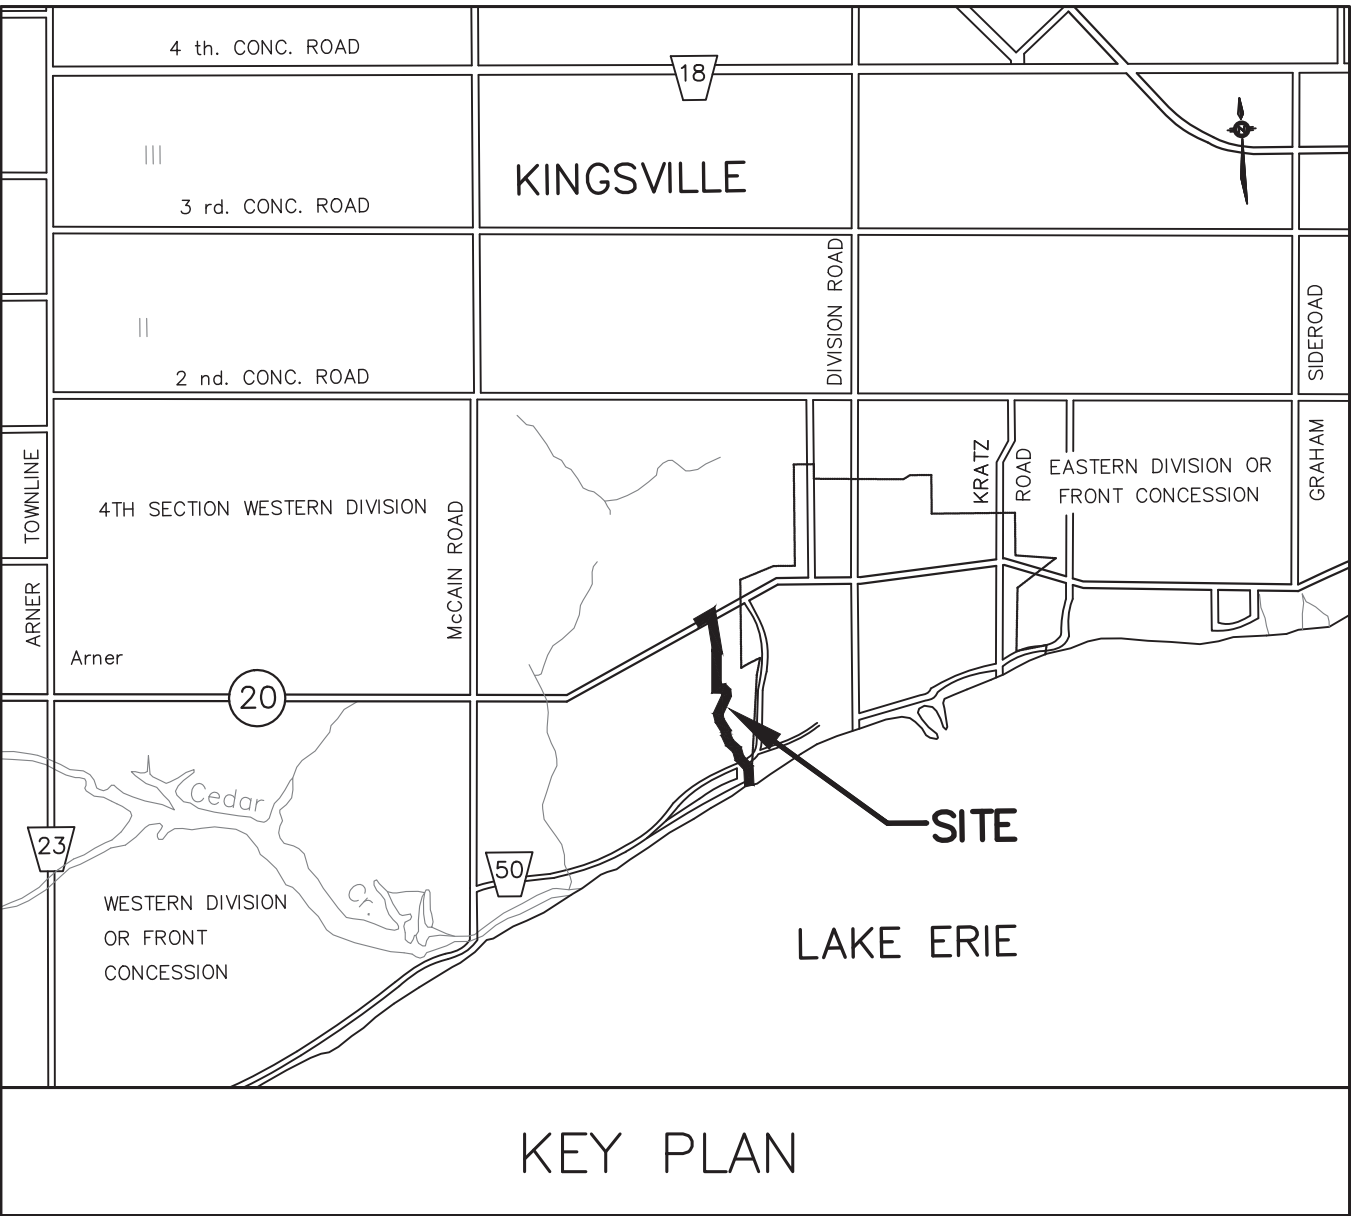

DETAIL 'A'
SCALE: 1:800

LEGEND

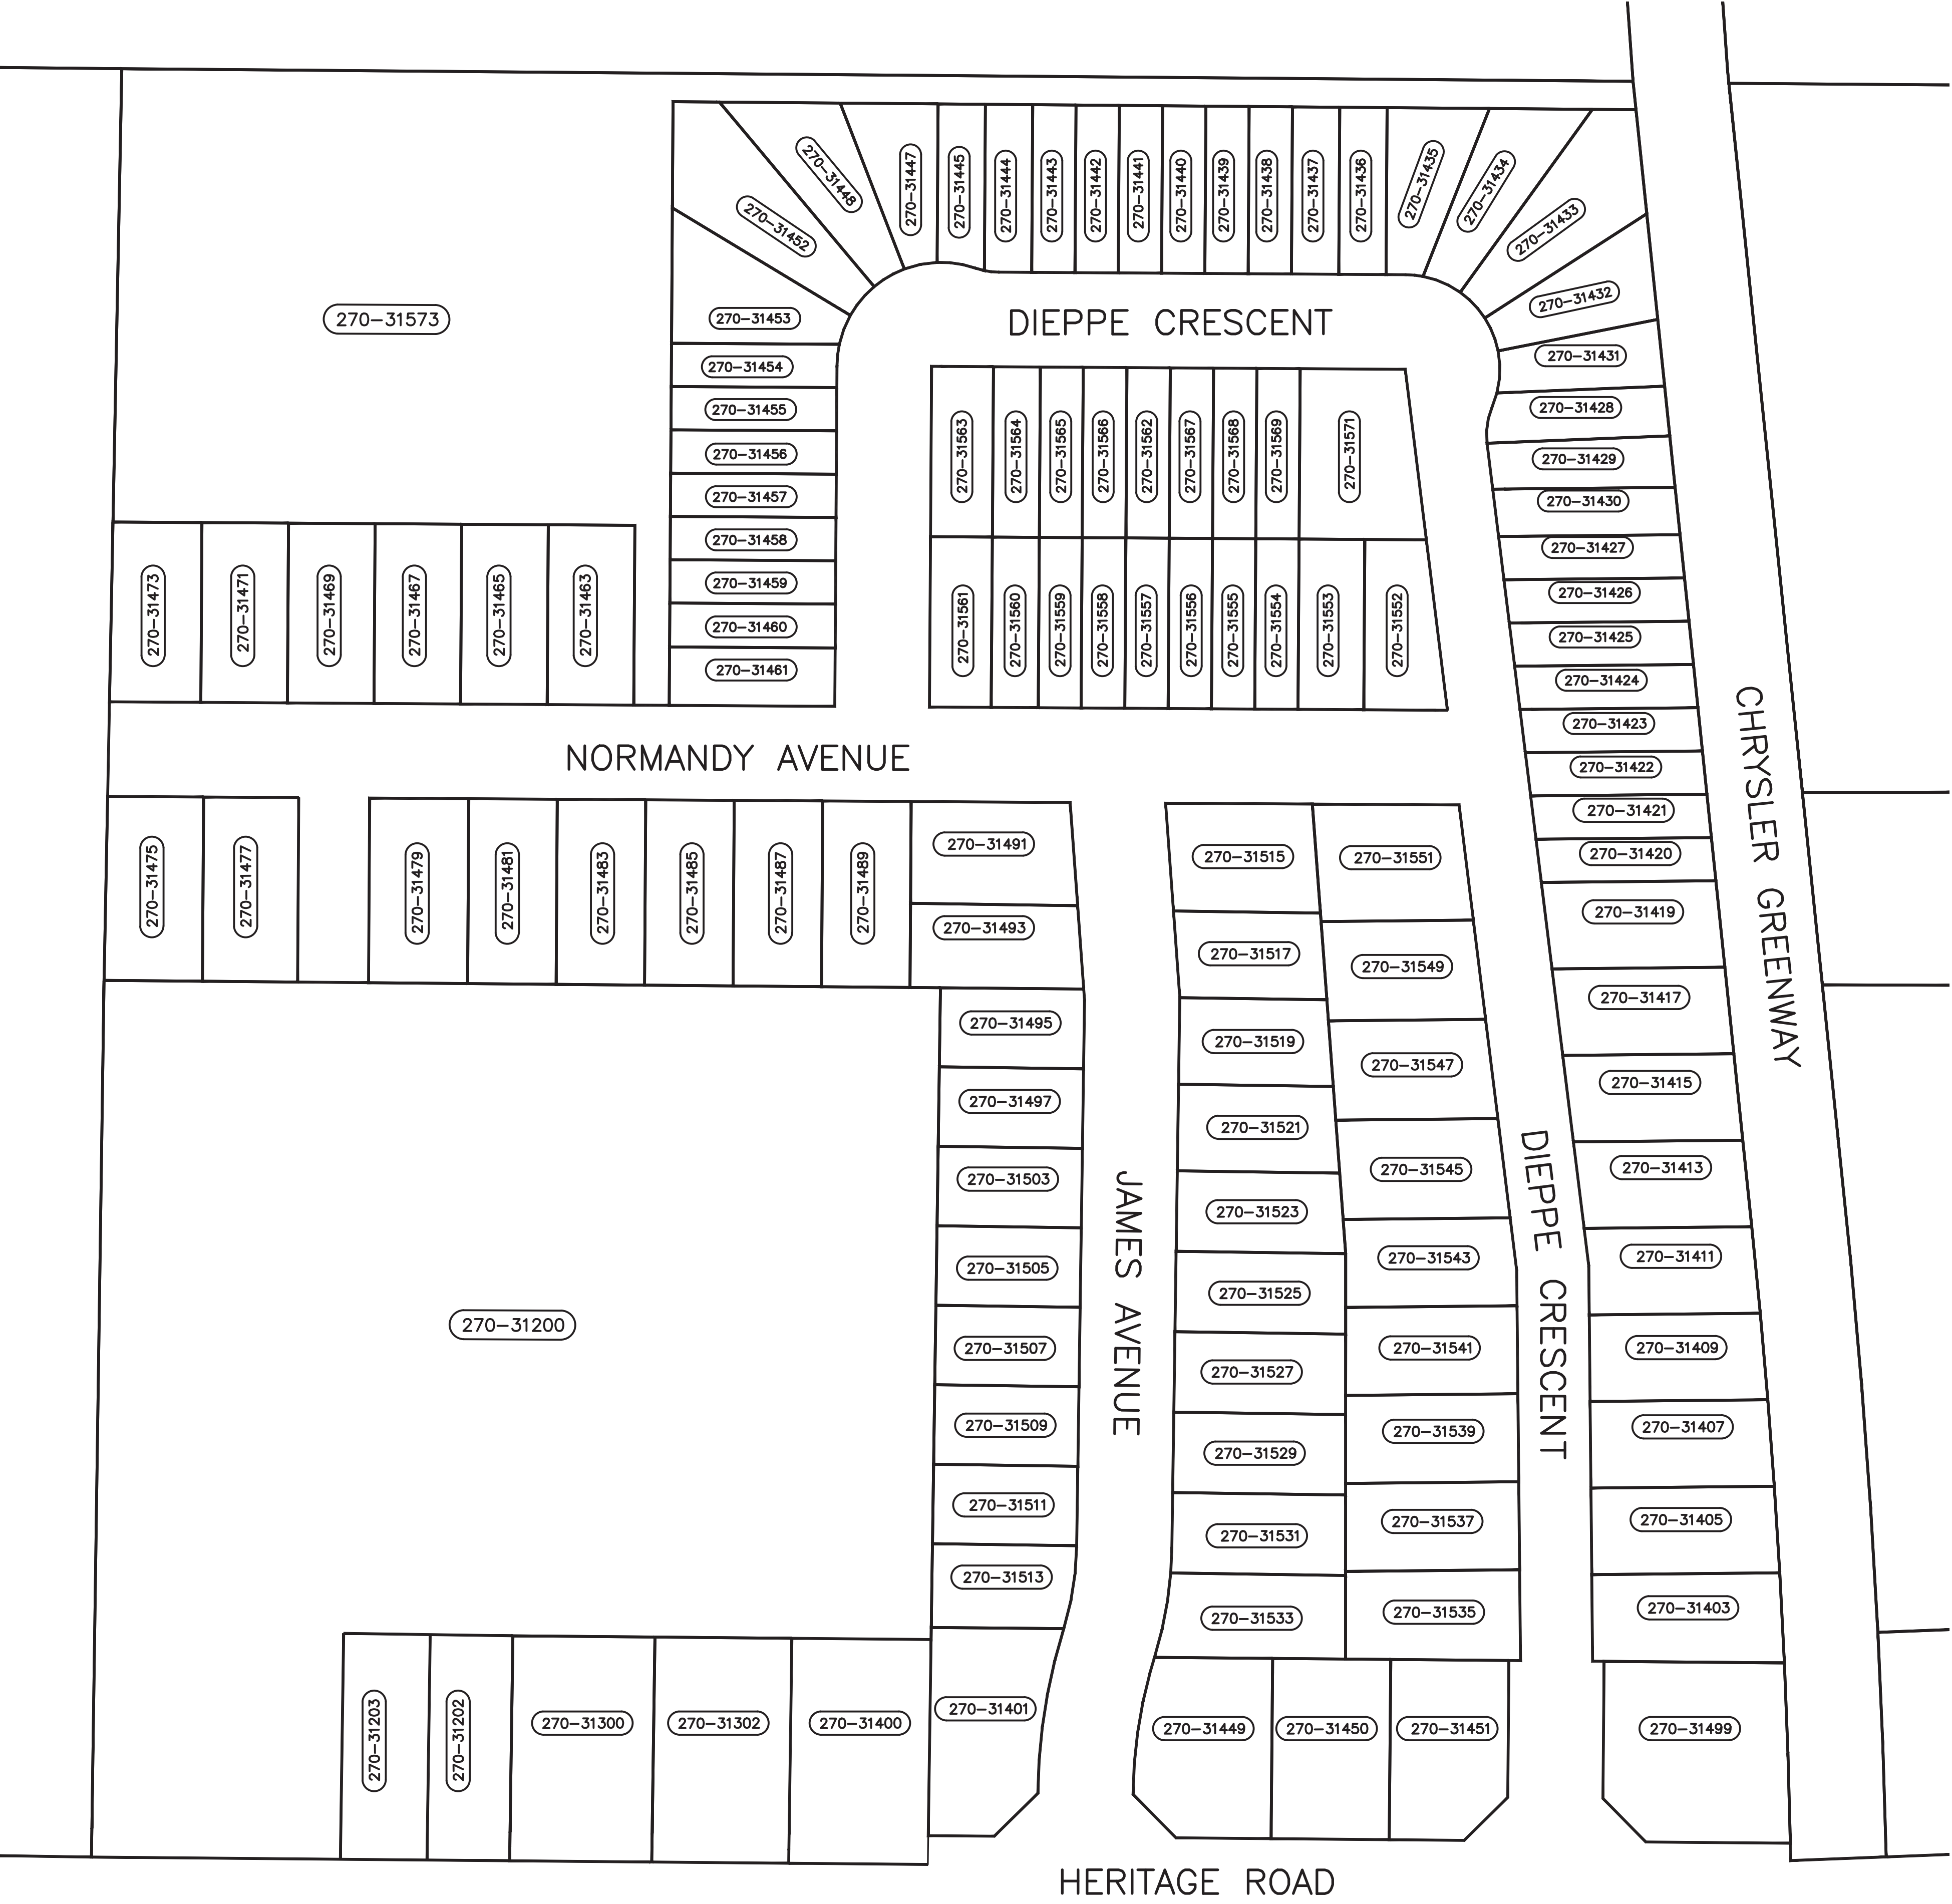

DRAINAGE AREA

010-12345

ROLL NUMBER




MUNICIPAL DRAIN

THIS PLAN HAS BEEN REDUCED IN SIZE FOR PRESENTATION PURPOSES AND THEREFORE IT IS NOT TO THE SCALES INDICATED. A FULL SIZE SET OF DRAWINGS IS AVAILABLE FOR REVIEW AT THE TOWN OFFICE



RC SPENCER ASSOCIATES INC.
Consulting Engineers
Windsor: 900 University Ave. W., Windsor, ON N9A 5R9
Leamington: 18 Talbot St. W., Leamington, ON N8H 1M4
Chatham-Kent: 49 Raleigh St., Chatham, ON N7M 2M6

Professional Engineers
Ontario

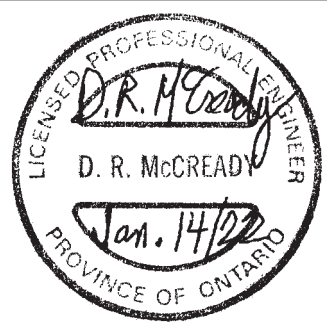

DESIGN	M.M.H.
CHECKED	D.M.
DRAWN	M.M.H.
CHECKED	D.M.
DATE	14 JAN. 2022
SCALE	AS SHOWN


MORLEY WIGLE DRAIN

BLOW-UP OF
LANDS AFFECTED

PROJECT NO.	14-424
SHEET NO.	2
OF	5



KEY PLAN

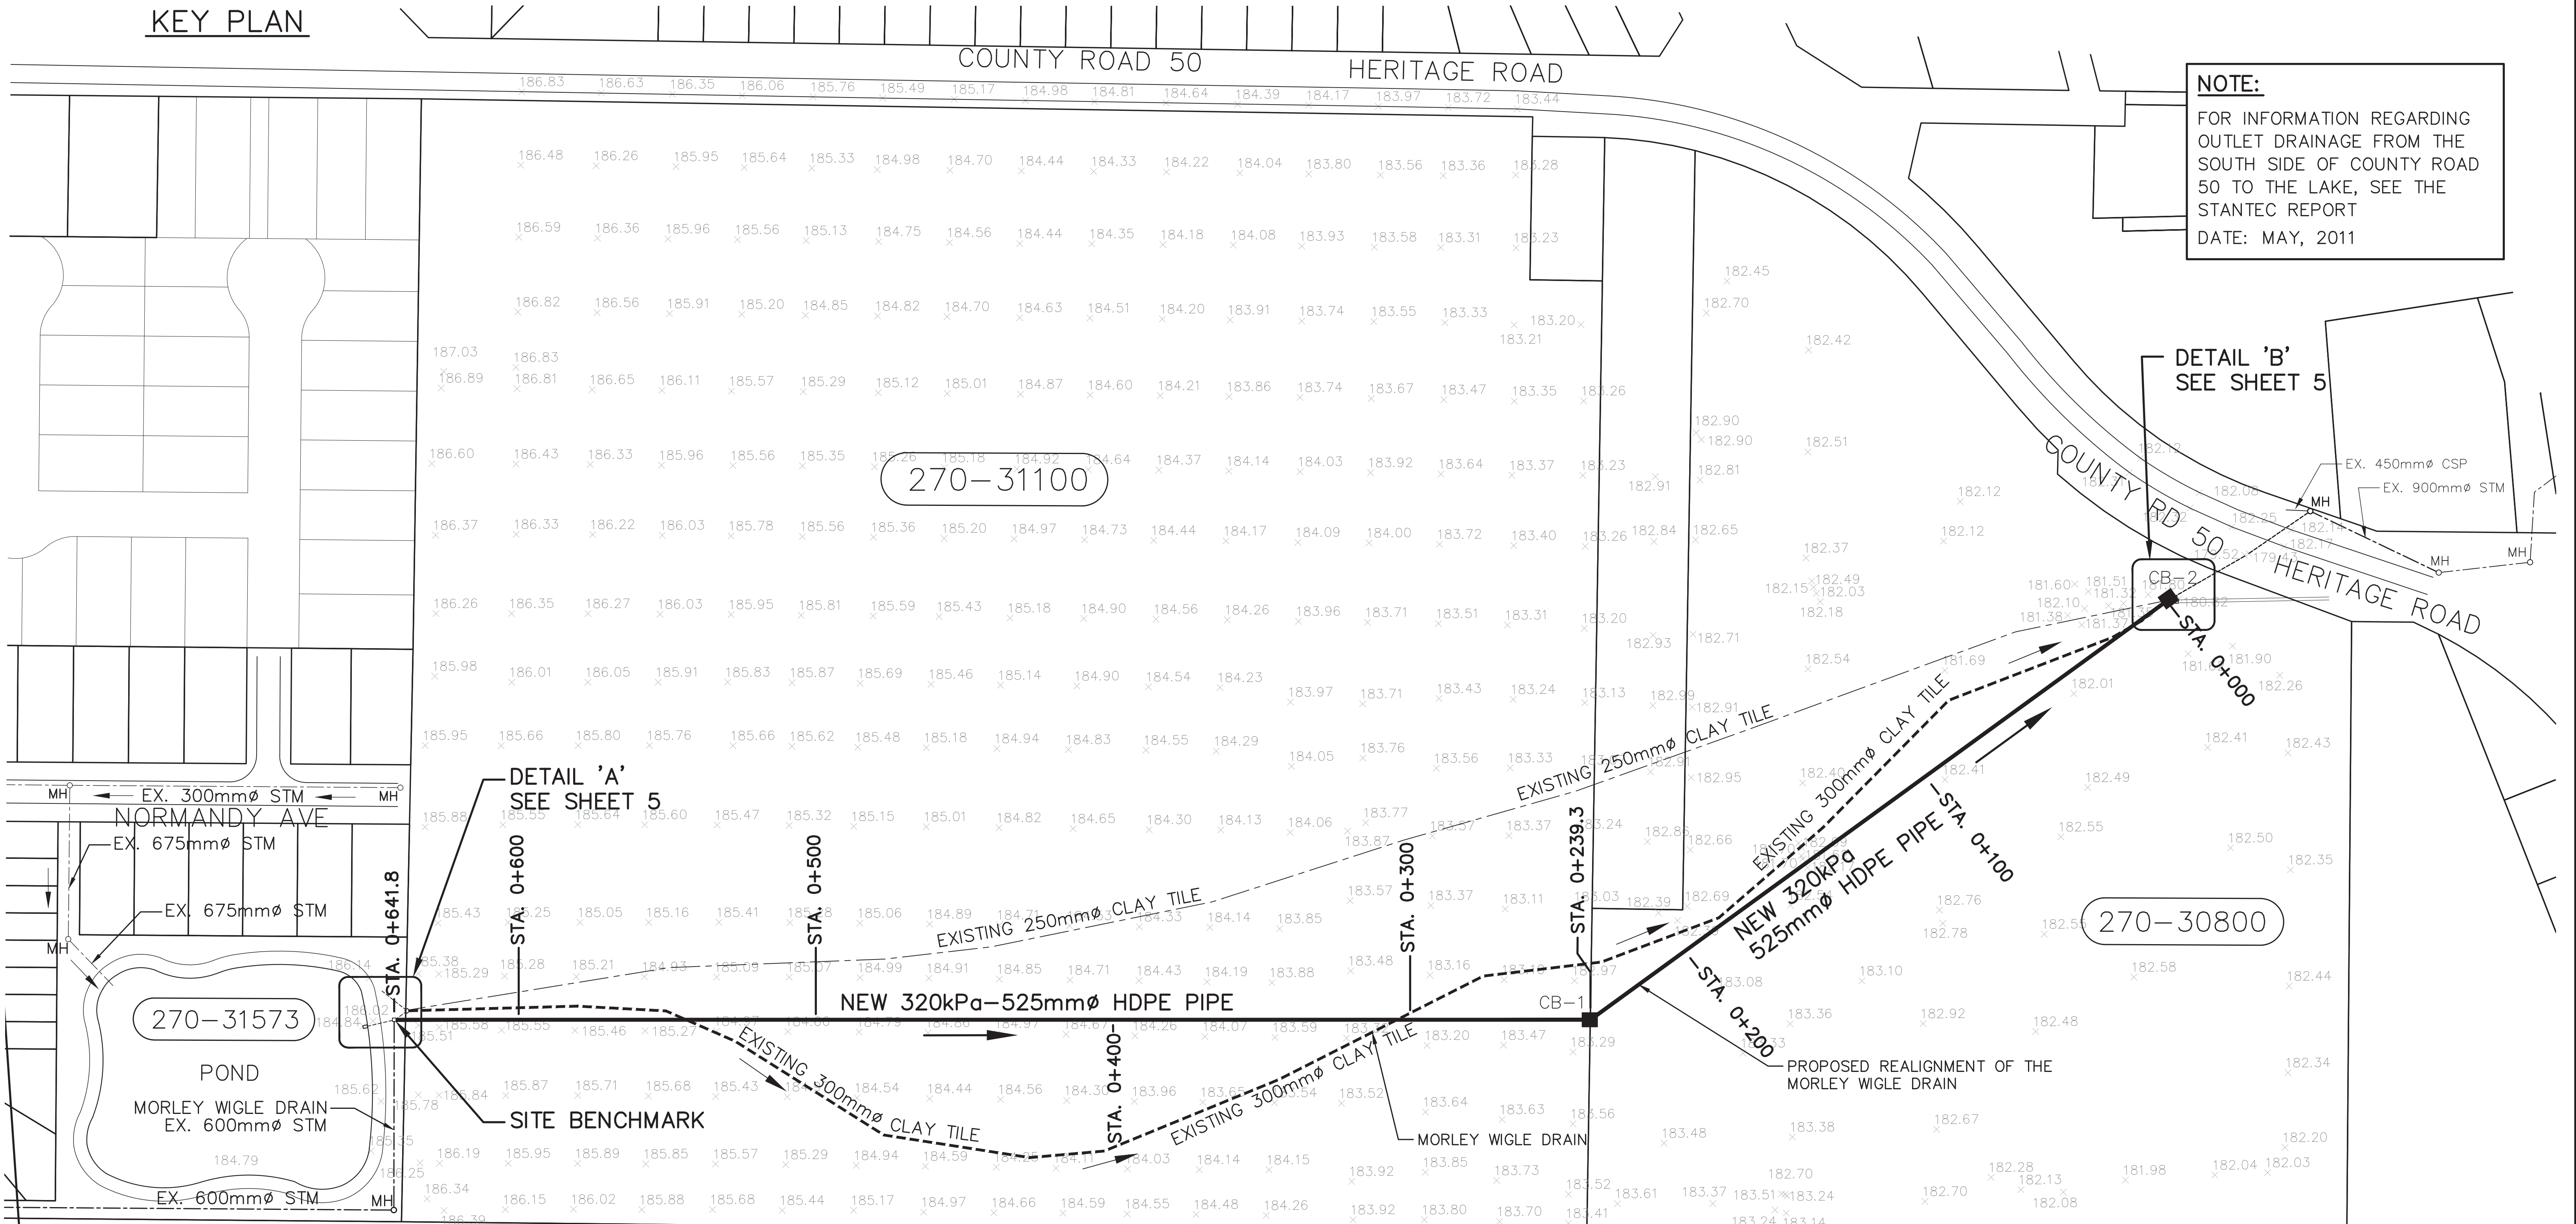

NOTE:
FOR INFORMATION REGARDING
OUTLET DRAINAGE FROM THE
SOUTH SIDE OF COUNTY ROAD
50 TO THE LAKE, SEE THE
STANTEC REPORT
DATE: MAY, 2011

DETAIL 'B'
SEE SHEET 5

DETAIL 'A'
SEE SHEET 5


BENCHMARK:
SITE BENCHMARK: TOP OF STEEL FRAME AND GRATE ON
EXISTING CATCHBASIN AT STATION 0+641.8

ELEV=185.380

LEGEND
———— PROPOSED DRAIN
REALIGNMENT
----- EXISTING PRIVATE
TILE DRAIN
----- EXISTING MORLEY
WIGLE DRAIN

NOTE:
THE EXISTING MORLEY WIGLE DRAIN
DOES NOT PROVIDE OUTLET TO ANY
OTHER LATERAL DRAIN TILES.

THIS PLAN HAS BEEN REDUCED IN SIZE
FOR PRESENTATION PURPOSES AND
THEREFORE IT IS NOT TO THE SCALES
INDICATED. A FULL SIZE SET OF DRAWINGS
IS AVAILABLE FOR REVIEW AT THE TOWN
OFFICE

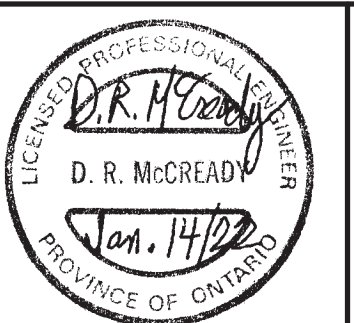


DESIGN	M.M.H.
CHECKED	D.M.
DRAWN	M.M.H.
CHECKED	D.M.
DATE	14 JAN, 2022
SCALE	1:1000

MORLEY WIGLE DRAIN


**SITE PLAN
EXISTING GRADING & DRAINAGE**

PROJECT NO.	14-424
SHEET NO.	3
OF	5

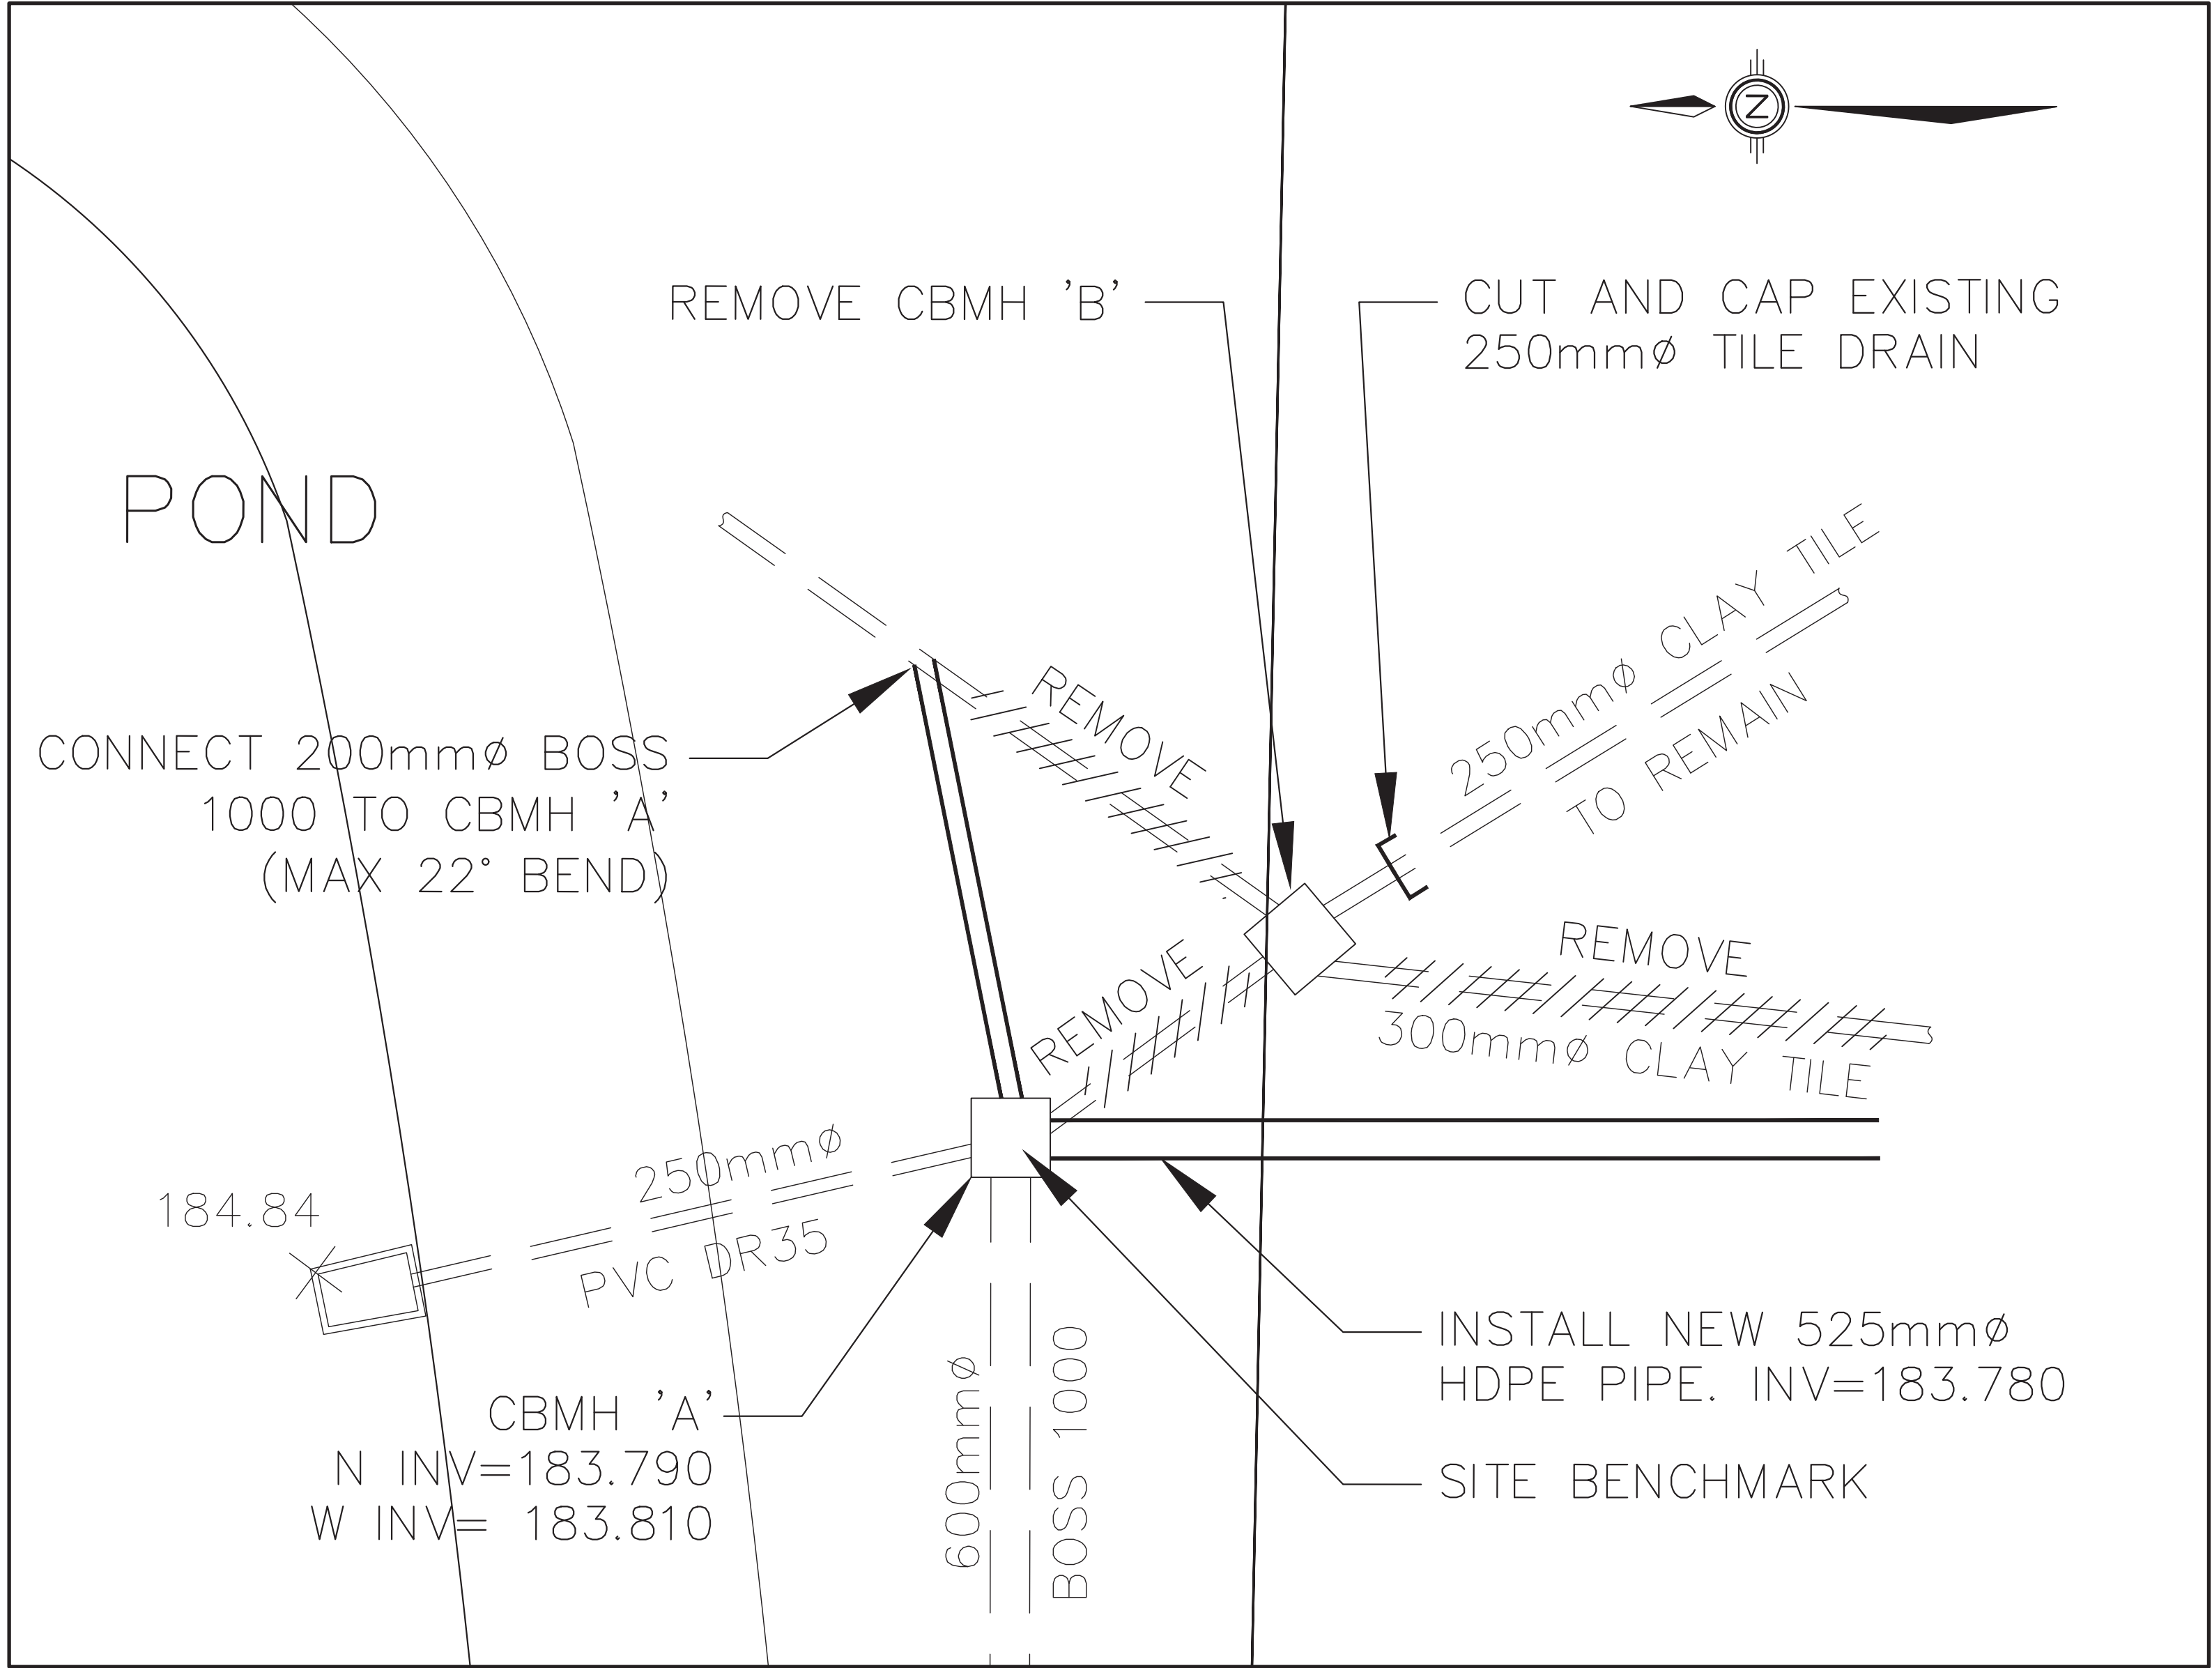

DETAIL 'A' (STA 0+641.8)


SCALE - N.T.S.

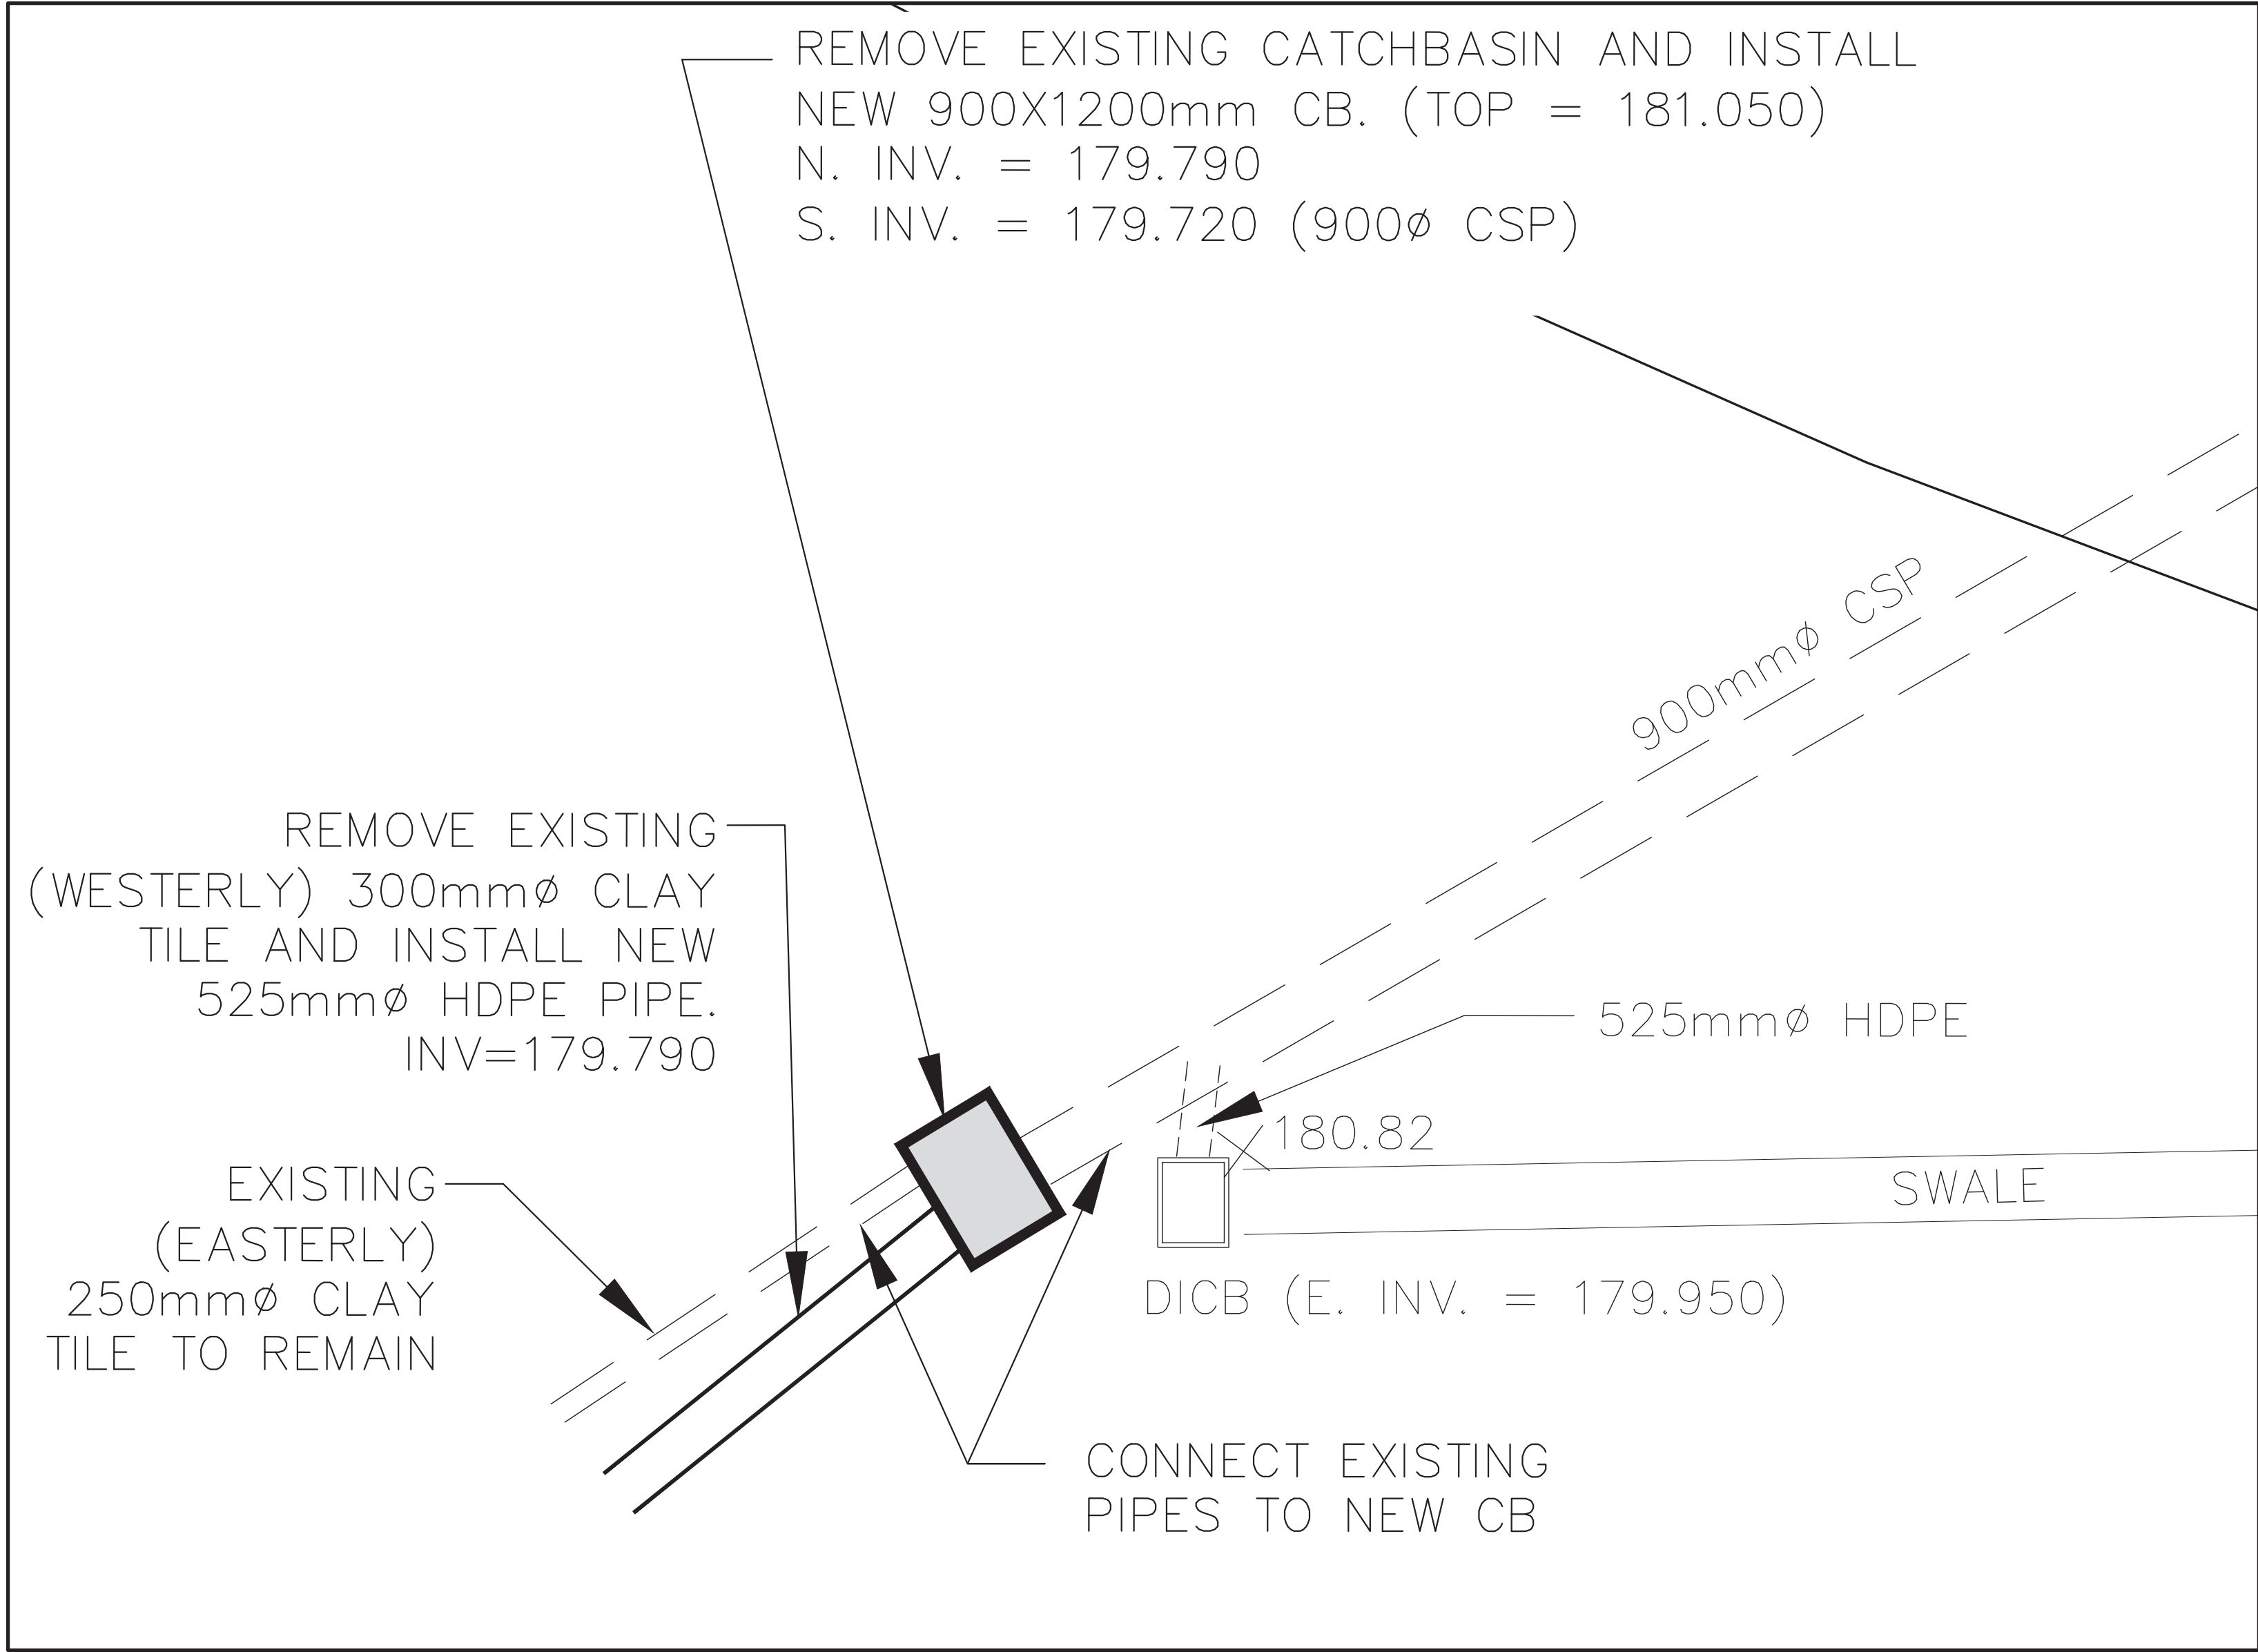

DETAIL 'B' (STA 0+000)

SCALE - N.T.S.

THIS PLAN HAS BEEN REDUCED IN SIZE FOR PRESENTATION PURPOSES AND THEREFORE IT IS NOT TO THE SCALES INDICATED. A FULL SIZE SET OF DRAWINGS IS AVAILABLE FOR REVIEW AT THE TOWN OFFICE

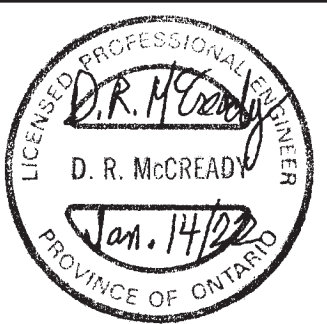

DESIGN	M.M.H.
CHECKED	D.M.
DRAWN	M.M.H.
CHECKED	D.M.
DATE	14 JAN, 2022
SCALE	N.T.S.

MORLEY WIGLE DRAIN
DETAILS

PROJECT NO.	14-424
SHEET NO.	5
OF	5